

APN: 010-053-01 & 010-053-02

NORTHPOINT
CONSULTING GROUP, INC.
1117 Samoa Blvd., Arcata, CA 95521

CLEARPATH CANYON, LLC.
APN:010-053-01 & 010-053-02
SITE "A" DETAILED AREA

PROJECT NO.:	AD
DRAWN BY:	LJM
DATE:	03/27/2024
SCALE:	AS SHOWN
SHEET	
C1	
20-098	



EXISTING SITE PLAN

 
CULTIVATION CANOPY NOTE:
OUTDOOR CULTIVATION CANOPY WILL BE PLANTED ON CONTOUR. IF TEMPORARY HOOPHOUSES ARE USED, TEMPORARY AG-EXEMPT HOOP STRUCTURES WILL FOLLOW ORDINANCE No.3132.

22x34 SHEET: 1"=80'
11x17 SHEET: 1"=160'

APN: 010-053-01 & 010-053-02

NORTHPOINT
CONSULTING GROUP, INC.
1117 Samoa Blvd., Arcata, CA 95521

PROJ NO. /	AD
DRAWN BY:	LJM
DATE:	03/27/2004
SCALE:	AS SHOWN
SHEET	
02	
20-098	




CULTIVATION CANOPY NOTE:
OUTDOOR CULTIVATION CANOPY WILL BE PLANTED ON CONTOUR, IF TEMPORARY HOOPHOUSES ARE USED, TEMPORARY AG-EXEMPT HOOP STRUCTURES WILL FOLLOW ORDINANCE No.3132.

CLEARPATH CANYON, LLC

SITE 'C' DETAILED AREA

APN: 010-053-01 & 010-053-02

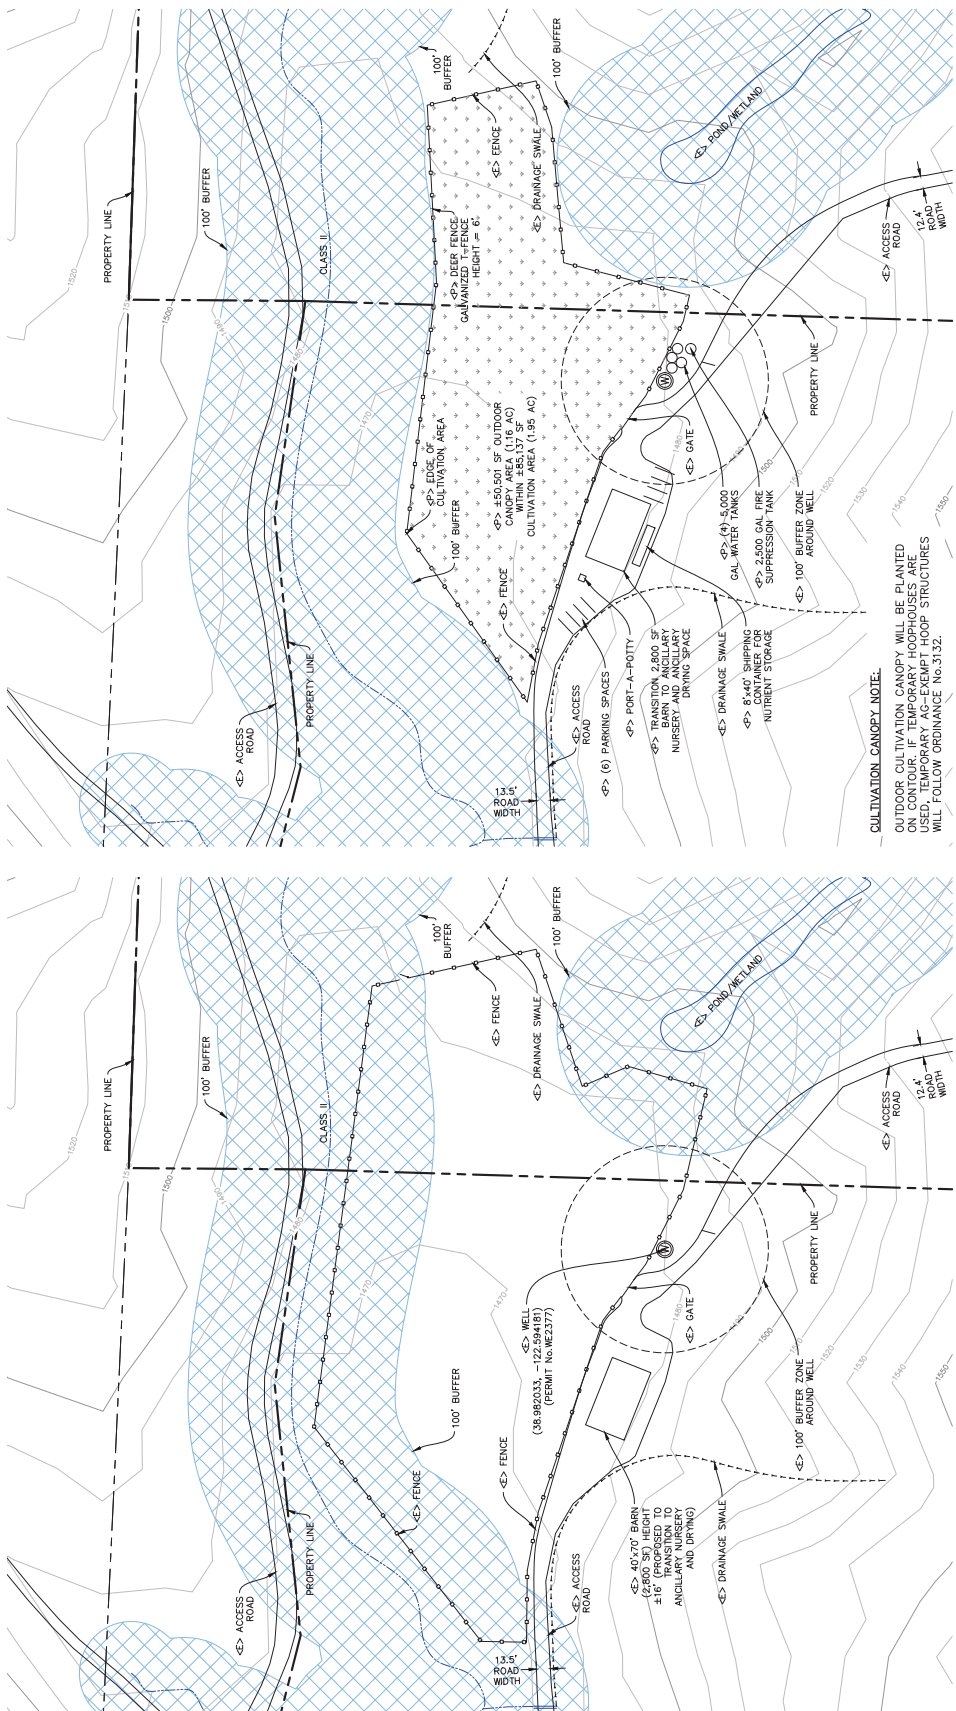

EXISTING SITE PLAN



PROPOSED SITE PLAN

CULTIVATION CANOPY NOTE:
OUTDOOR CULTIVATION CANOPY WILL BE PLANTED ON CONTOUR. IF TEMPORARY HOPOUSES ARE USED, TEMPORARY ACCESS HOOP STRUCTURES WILL FOLLOW GRADUANCE NO.3132.

CLEARPATH CANYON, LLC.
APN: 010-053-01 & 010-053-02
SITE 'C' DETAILED AREA


NORTHPOINT CONSULTING GROUP, INC.
1117 Samoa Blvd., Arcata, CA 95521

DATE	10/20/2024
DESIGNED BY	JD
CHECKED BY	JD
IN CHARGE	JD
PROJECT NO.	22-0001
SHEET NO.	1

APN: 010-053-01 & 010-053-02

NORTHPOINT
CONSULTING GROUP, INC.
1117 Samoa Blvd., Arcata, CA 95521

PROJ NO./	AD
DRAWN BY:	LJM
DATE	03/27/2022
SCALE	AS SHOWN
SHEET	
C4	
20-098	

 

EXISTING SITE PLAN

22x34 SHEET: 1"=80'
11x17 SHEET: 1"=160'

CULTIVATION CANOPY NOTE:

APN: 010-053-01 & 010-053-02

NORTHPOINT
CONSULTING GROUP, INC.
1117 Samoa Blvd., Arcata, CA 95521

PROJECT	AD
DRAWN BY	LJM
DATE	03/27/2022
SCALE	AS SHOWN
SHEET	
C5	
20-098	



EXISTING SITE PLAN

22x34 SHEET: 1"=40'
11x17 SHEET: 1"=80'

CULTIVATION CANOPY NOTE:
OUTDOOR CULTIVATION CANOPY WILL BE PLANTED ON CONTOUR, IF TEMPORARY HOOPHOUSES ARE USED, TEMPORARY AG-EXEMPT HOOP STRUCTURES WILL FOLLOW ORDINANCE No.3132.

APN: 010-053-01 & 010-053-02

APN: 010-053-01 & 010-053-02

NORTHPOINT
CONSULTING GROUP, INC.
1117 Samoa Blvd., Arcata, CA 95521

SECURITY PLAN

PROJECT NO. /	AD
DRAWN BY:	LJM
DATE	03/27/2024
SCALE	AS SHOWN

C6

- FENCE
- MOTION SENSOR, LIGHTING & SECURITY CAMERA

22x34 SHEET: 1"=200'
11x17 SHEET: 1"=400'

March 27, 2024 - 10:46 Dwg Name: P:\Richard Knott Consulting - Lake Vito Forms - 20-096\CAD\CLEARPATH CANYON LLC - MAJOR USE PERMIT.dwg Updated By: LHMcloughlin

